





FRONT ELEVATION


* GABLE SIDING, GABLE VENT TO BE
INSTALLED AT SITE BY OTHERS.

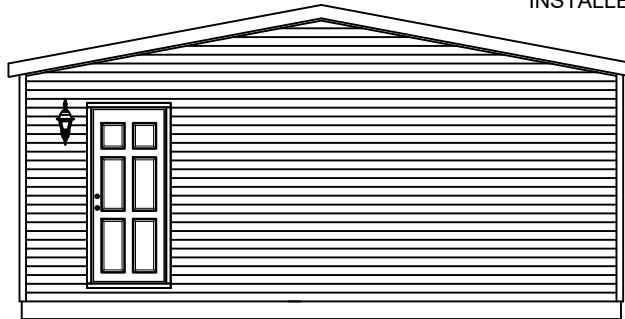

LEFT ELEVATION

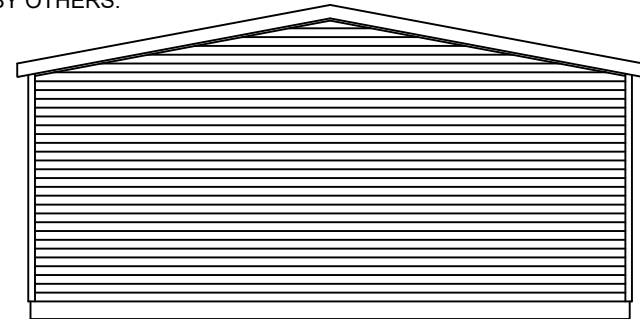

RIGHT ELEVATION

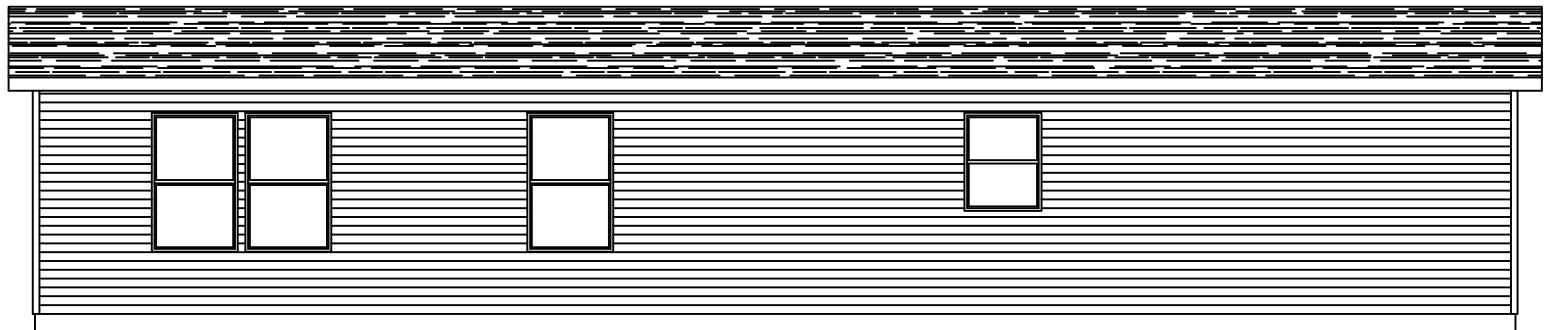

REAR ELEVATION

FIELD NOTES

* INDICATES ITEMS INSTALLED
BY OTHERS AT SITE.


CLAYTON WAKARUSA
Div. of CMH Manufacturing West Inc.
66700 STATE ROAD 19 P.O. BOX 406
WAKARUSA, INDIANA 46573

PULSE PRODUCT
ELEVATIONS

REVISION BOX

DRAWN BY: MDK
DATE: 2/8/2017
2020 MODEL

736RE

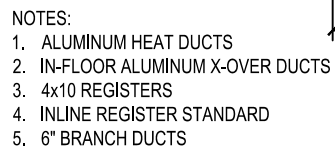


GENERAL NOTES:

- 1. CLOSET LIGHTS TO BE A MIN. 12" FROM SHELF AND CLOSED TYPE.
- 2. HEAT TAPE RECEP LOCATED WITHIN 24" OF WATER INLET.
- 3. WIRE IS NM CABLE WITH GROUND.
- 4. LAVATORY RECEPS ARE GFI PROTECTED.
- 5. ALL KITCHEN RECEPTACLES OVER COUNTER TOPS ARE GFCI PROTECTED.
- 6. OUTSIDE RECEP IS GFI PROTECTED.
- 7. ALL RECEPS LOCATED OUTSIDE ARE PROTECTED WITH WEATHER-PROOF COVERS.
- 8. EXTERIOR FIXTURES ARE LISTED FOR OUTSIDE USE.
- 9. ALL SMOKE ALARMS ARE CEILING MOUNTED. THEY ARE ON A DEDICATED CIRCUIT WITH ONE OR MORE FIXTURES INCLUDED. THEY ARE MULTIPLE STATION ALARMS, WITH BATTERY BACK UP. ANY SMOKE ALARM LOCATED WITHIN 20 FEET OF A KITCHEN MUST HAVE A TEMPORARY SILENCING FEATURE.

ELECTRICAL SCHEDULE

CIR. NO.	CIRCUIT DESCRIPTION	BREAKER	WIRE SIZE	CIR. NO.	CIRCUIT DESCRIPTION	BREAKER	WIRE SIZE
1	PORTABLE APPLIANCE	20	12-2 W/G	12	WASHER	20	12-2 W/G
2	PORTABLE APPLIANCE	20	12-2 W/G	13	CLOTHES DRYER	30	10-3 W/G
3	PORTABLE APPLIANCE	20	12-2 W/G	* 14	WATER HEATER (1650 WATTS) (OPTIONAL)	20	12-2 W/G
4	GENERAL LIGHTING	15	14-2 W/G	* 15	WATER HEATER (4500 WATTS) (OPTIONAL)	25	10-2 W/G
5	GENERAL LIGHTING	15	14-2 W/G	16	RANGE (12.5 KW MAX) (OPTIONAL)	40	8-3 W/G
6	GENERAL LIGHTING	15	14-2 W/G	17	WALL OVEN / COOKTOP	30	10-2 W/G
7	GENERAL LIGHTING	15	14-2 W/G	18	FREEZER (OPTIONAL)	20	12-2 W/G
8	BATH GFCI CIRCUIT	20	12-2 W/G	19	DISHWASHER / CARBAGE DISPOSAL (OPT)	20	12-2 W/G
9	SMOKE DETECTORS	15	14-3 W/G	20	MICROWAVE OVEN (OPTIONAL)	15	14-2 W/G
10	ELECTRIC FURNACE			21	TRASH COMPACTOR (OPTIONAL)	15	14-2 W/G
	1. ALTERNATE CIRCUIT	60	6-6-8 W/G	** 22	WHIRLPOOL TYPE TUB	20	12-2 W/G
	2. ALTERNATE CIRCUIT (WIRE #1)	50	6-6-8 W/G				
	(WIRE #2)	20	12-2 W/G				
11	FURNACE - GAS (OPTIONAL)	15	14-2 W/G				

* LOCK-OUT BREAKER PROVIDED WHEN NOT WITHIN SITE OF PANEL
** INDICATES CIRCUIT IS GROUND FAULT PROTECTED (GFCI)

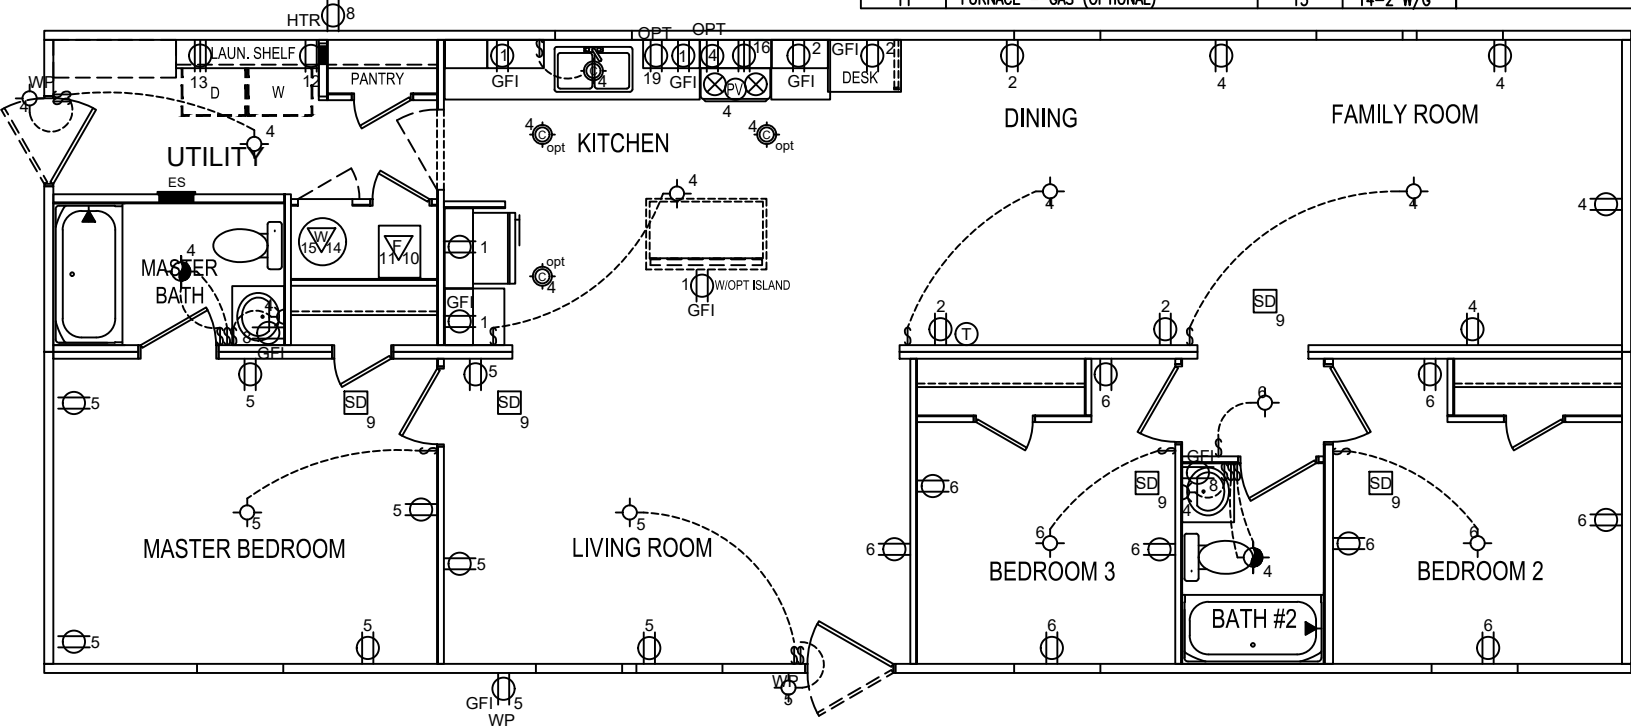

SYMBOL SCHEDULE	
SYMBOL	DESCRIPTION
⊖	COAX/PHONE/DATA JACK
⊙	SMOKE DETECTOR
⊕	SERVICE PANEL
⊖	WEATHER PROOF FUTURE
⊖	POWER VENT W/LIGHT
⊖	GROUND FAULT PROTECTED
⊖	POWER VENT
⊖	JUNCTION BOX
⊖	WATER HEATER
⊖	PENDANT LIGHT FIXTURE
⊖	LIGHT FIXTURE
⊖	RECESSED CAN LIGHT "IC" LISTED
⊖	DUPLEX RECEPTACLE (15A/115V)
⊖	DRYER RECEPTACLE (30A/230V)
⊖	WALL SWITCH
⊖	THREE WAY WALL SWITCH
⊖	THERMOSTAT
⊖	FURNACE
⊖	PHONE JACK
⊖	CABLE JACK


CLAYTON WAKARUSA
Div. of CMH Manufacturing West Inc.
66700 STATE ROAD 19 P.O. BOX 406
WAKARUSA, INDIANA 46573

PULSE PRODUCT
ELECTRICAL LAYOUT

REVISION BOX

DRAWN BY: MDK
DATE: 2/8/2017
2020 MODEL

736RE

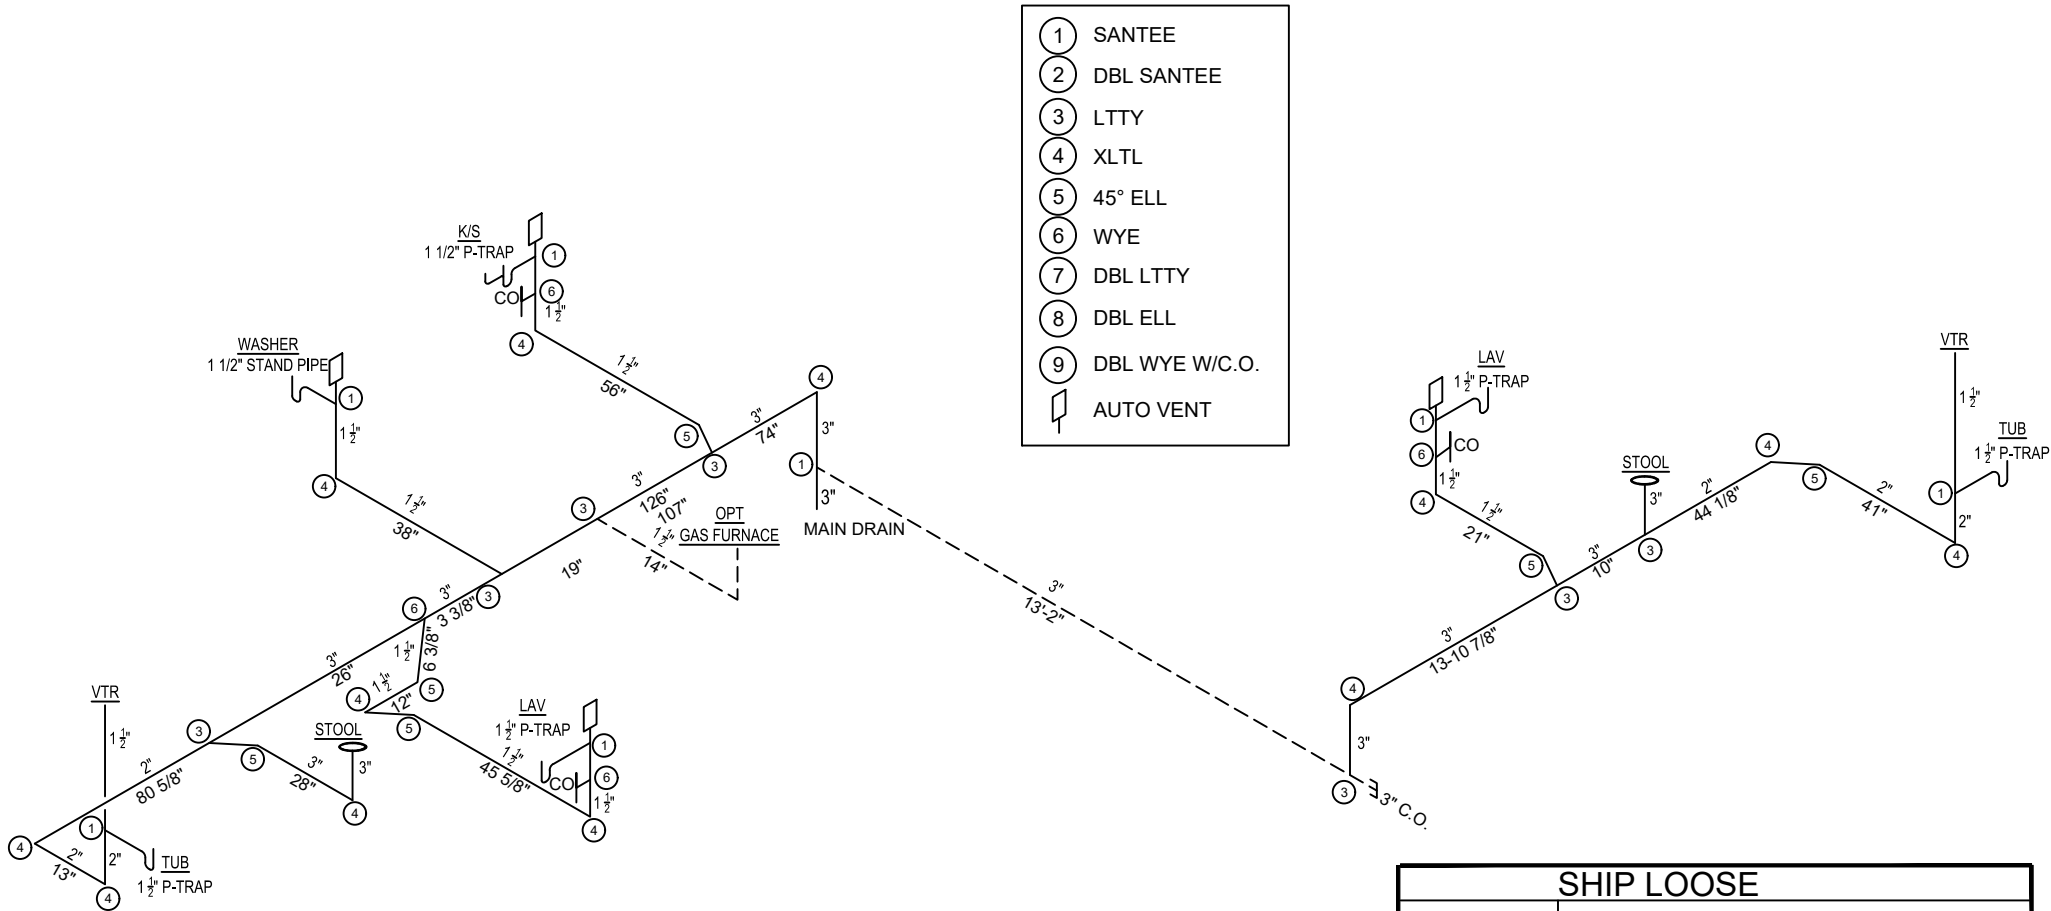

NOTE:

1. ALL PIPE AND FITTINGS ARE ABS SCHEDULE 40.
2. ASSEMBLY OF PIPE AND FITTINGS PER CONTAINER OF GLUE AND SOLVENT.
3. MATERIAL, PIPE, AND FITTINGS BY MANUFACTURE.
4. PIPING TO BE SUPPORTED AT 4'-0" AND 1/4" PER FOOT SLOPE MAINTAINED.
5. CUT PIPE TO LENGTH, COUPLERS ARE PROVIDED.
6. DASHED LINES INDICATE FIELD INSTALLED PIPE.
7. A COPY OF THIS LAYOUT TO ACCOMPANY UNIT AS PART OF THE INSTALLATION INSTRUCTIONS.


SHIP LOOSE	
QUANTITY	DESCRIPTION
1	3" LTTY
1	3" SANTEE
1	3" COUPLING
1	3" C/O W/PLUG
20'	3" PIPE

CLAYTON WAKARUSA
Div. of CMH Manufacturing West Inc.
66700 STATE ROAD 19 P.O. BOX 406
WAKARUSA, INDIANA 46573

PULSE PRODUCT
PLUMBING DWV LAYOUT

REVISION BOX

DRAWN BY: MDK
DATE: 2/8/2017
2020 MODEL
736RE

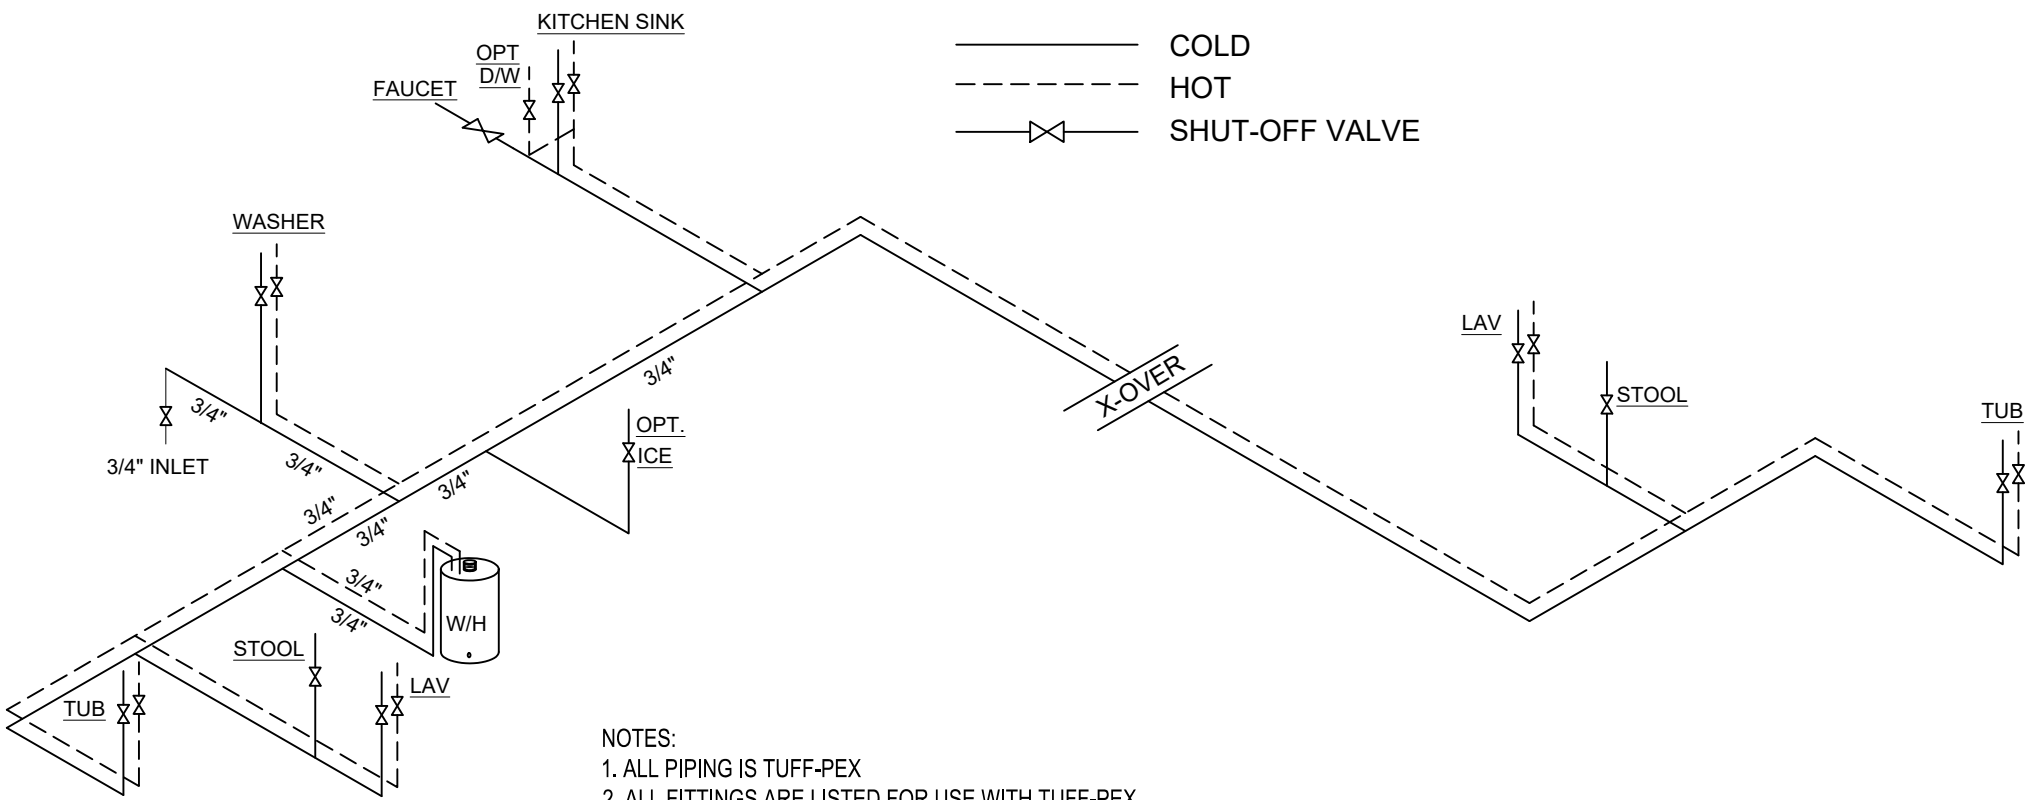


_____ COLD
 - - - - - HOT
 — X — SHUT-OFF VALVE

- NOTES:
1. ALL PIPING IS TUFF-PEX
 2. ALL FITTINGS ARE LISTED FOR USE WITH TUFF-PEX
 3. ALL LINES 1/2" UNLESS OTHERWISE SPECIFIED
 4. MAIN SHUT-OFF INSTALLED AT INLET. ALL OTHER SHUT-OFFS ARE OPTIONAL.
 5. WATER HEATER TO BE INSTALLED IN ACCORDANCE WITH THE MANUFACTURERS INSTALLATION INSTRUCTIONS.

NOTE:

- 1: ALL PIPE AND FITTINGS ARE B.I.
- 2: TOTAL DESIGN LENGTH IS 20 FEET.
- 3: TOTAL MAX. DESIGN IS 166,000 BTUH.
- 4: $\times$ DENOTES SHUT OFF VALVE.
- 5: ALL PIPE 1/2" UNLESS OTHERWISE STATED.

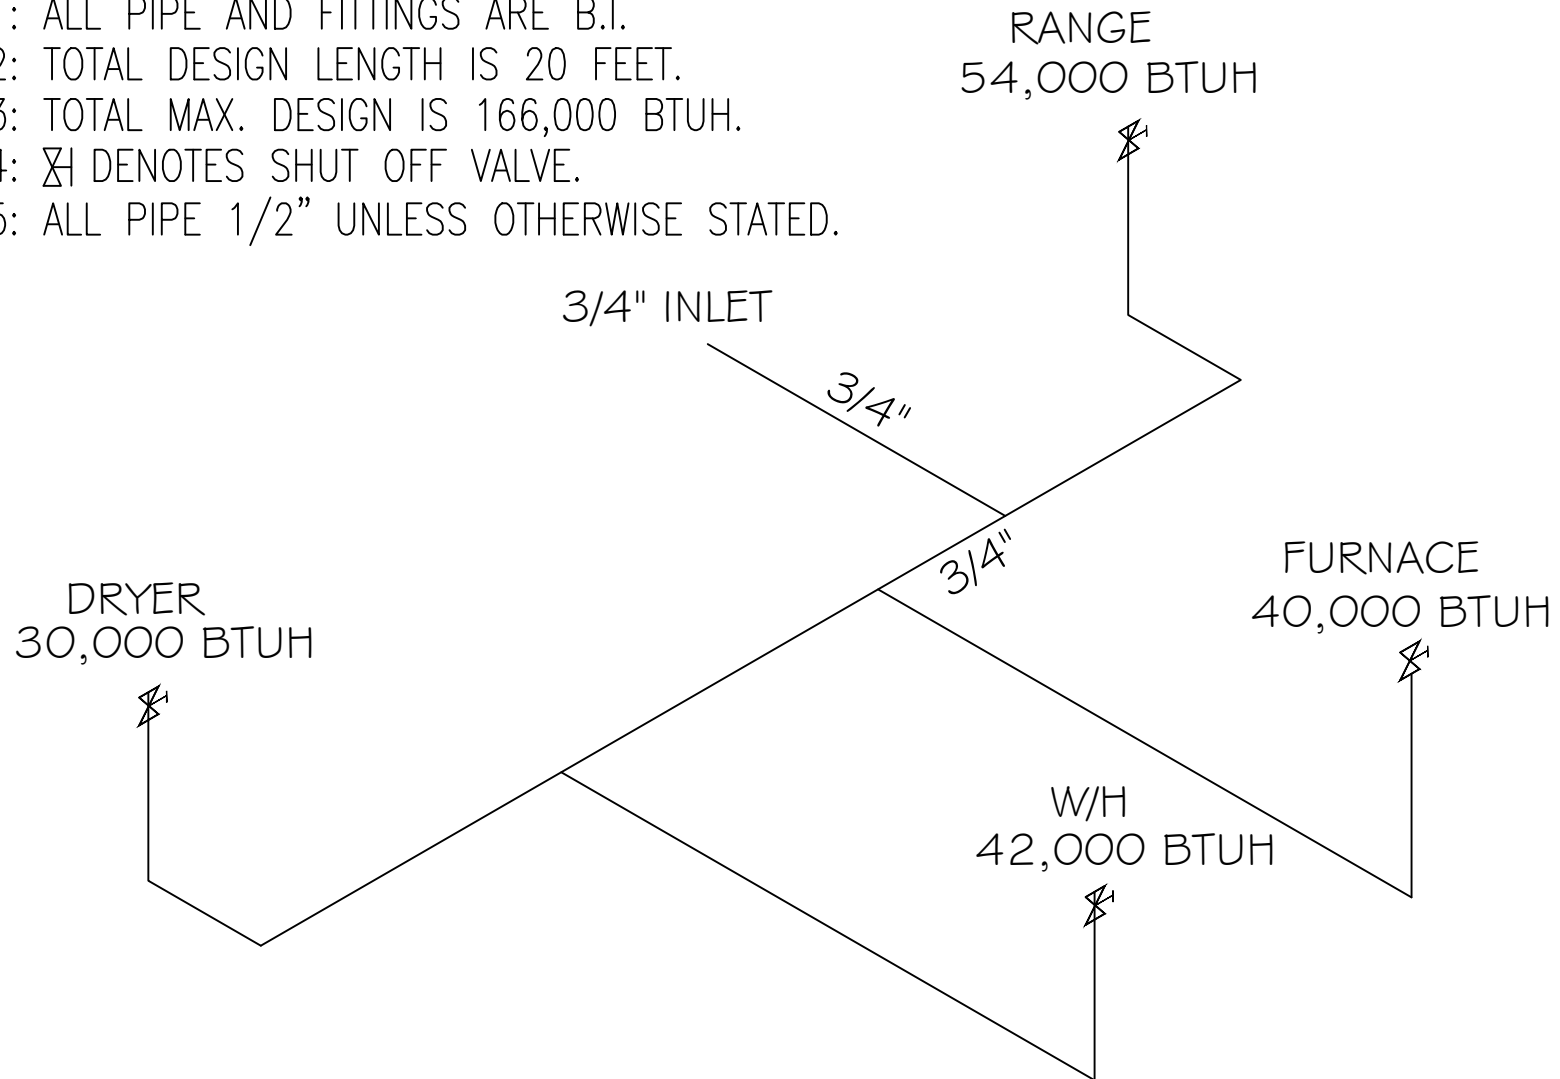

CLAYTON WAKARUSA
Div. of CMH Manufacturing West Inc.
66700 STATE ROAD 19 P.O. BOX 406
WAKARUSA, INDIANA 46573

PULSE PRODUCT
PLUMBING GAS LINE LAYOUT

REVISION BOX

DRAWN BY: MDK
DATE: 2/8/2017

2020 MODEL
736RE

